
 



**PARTIAL MECHANICAL PLAN**  
SCALE: 1/4" = 1'-0"

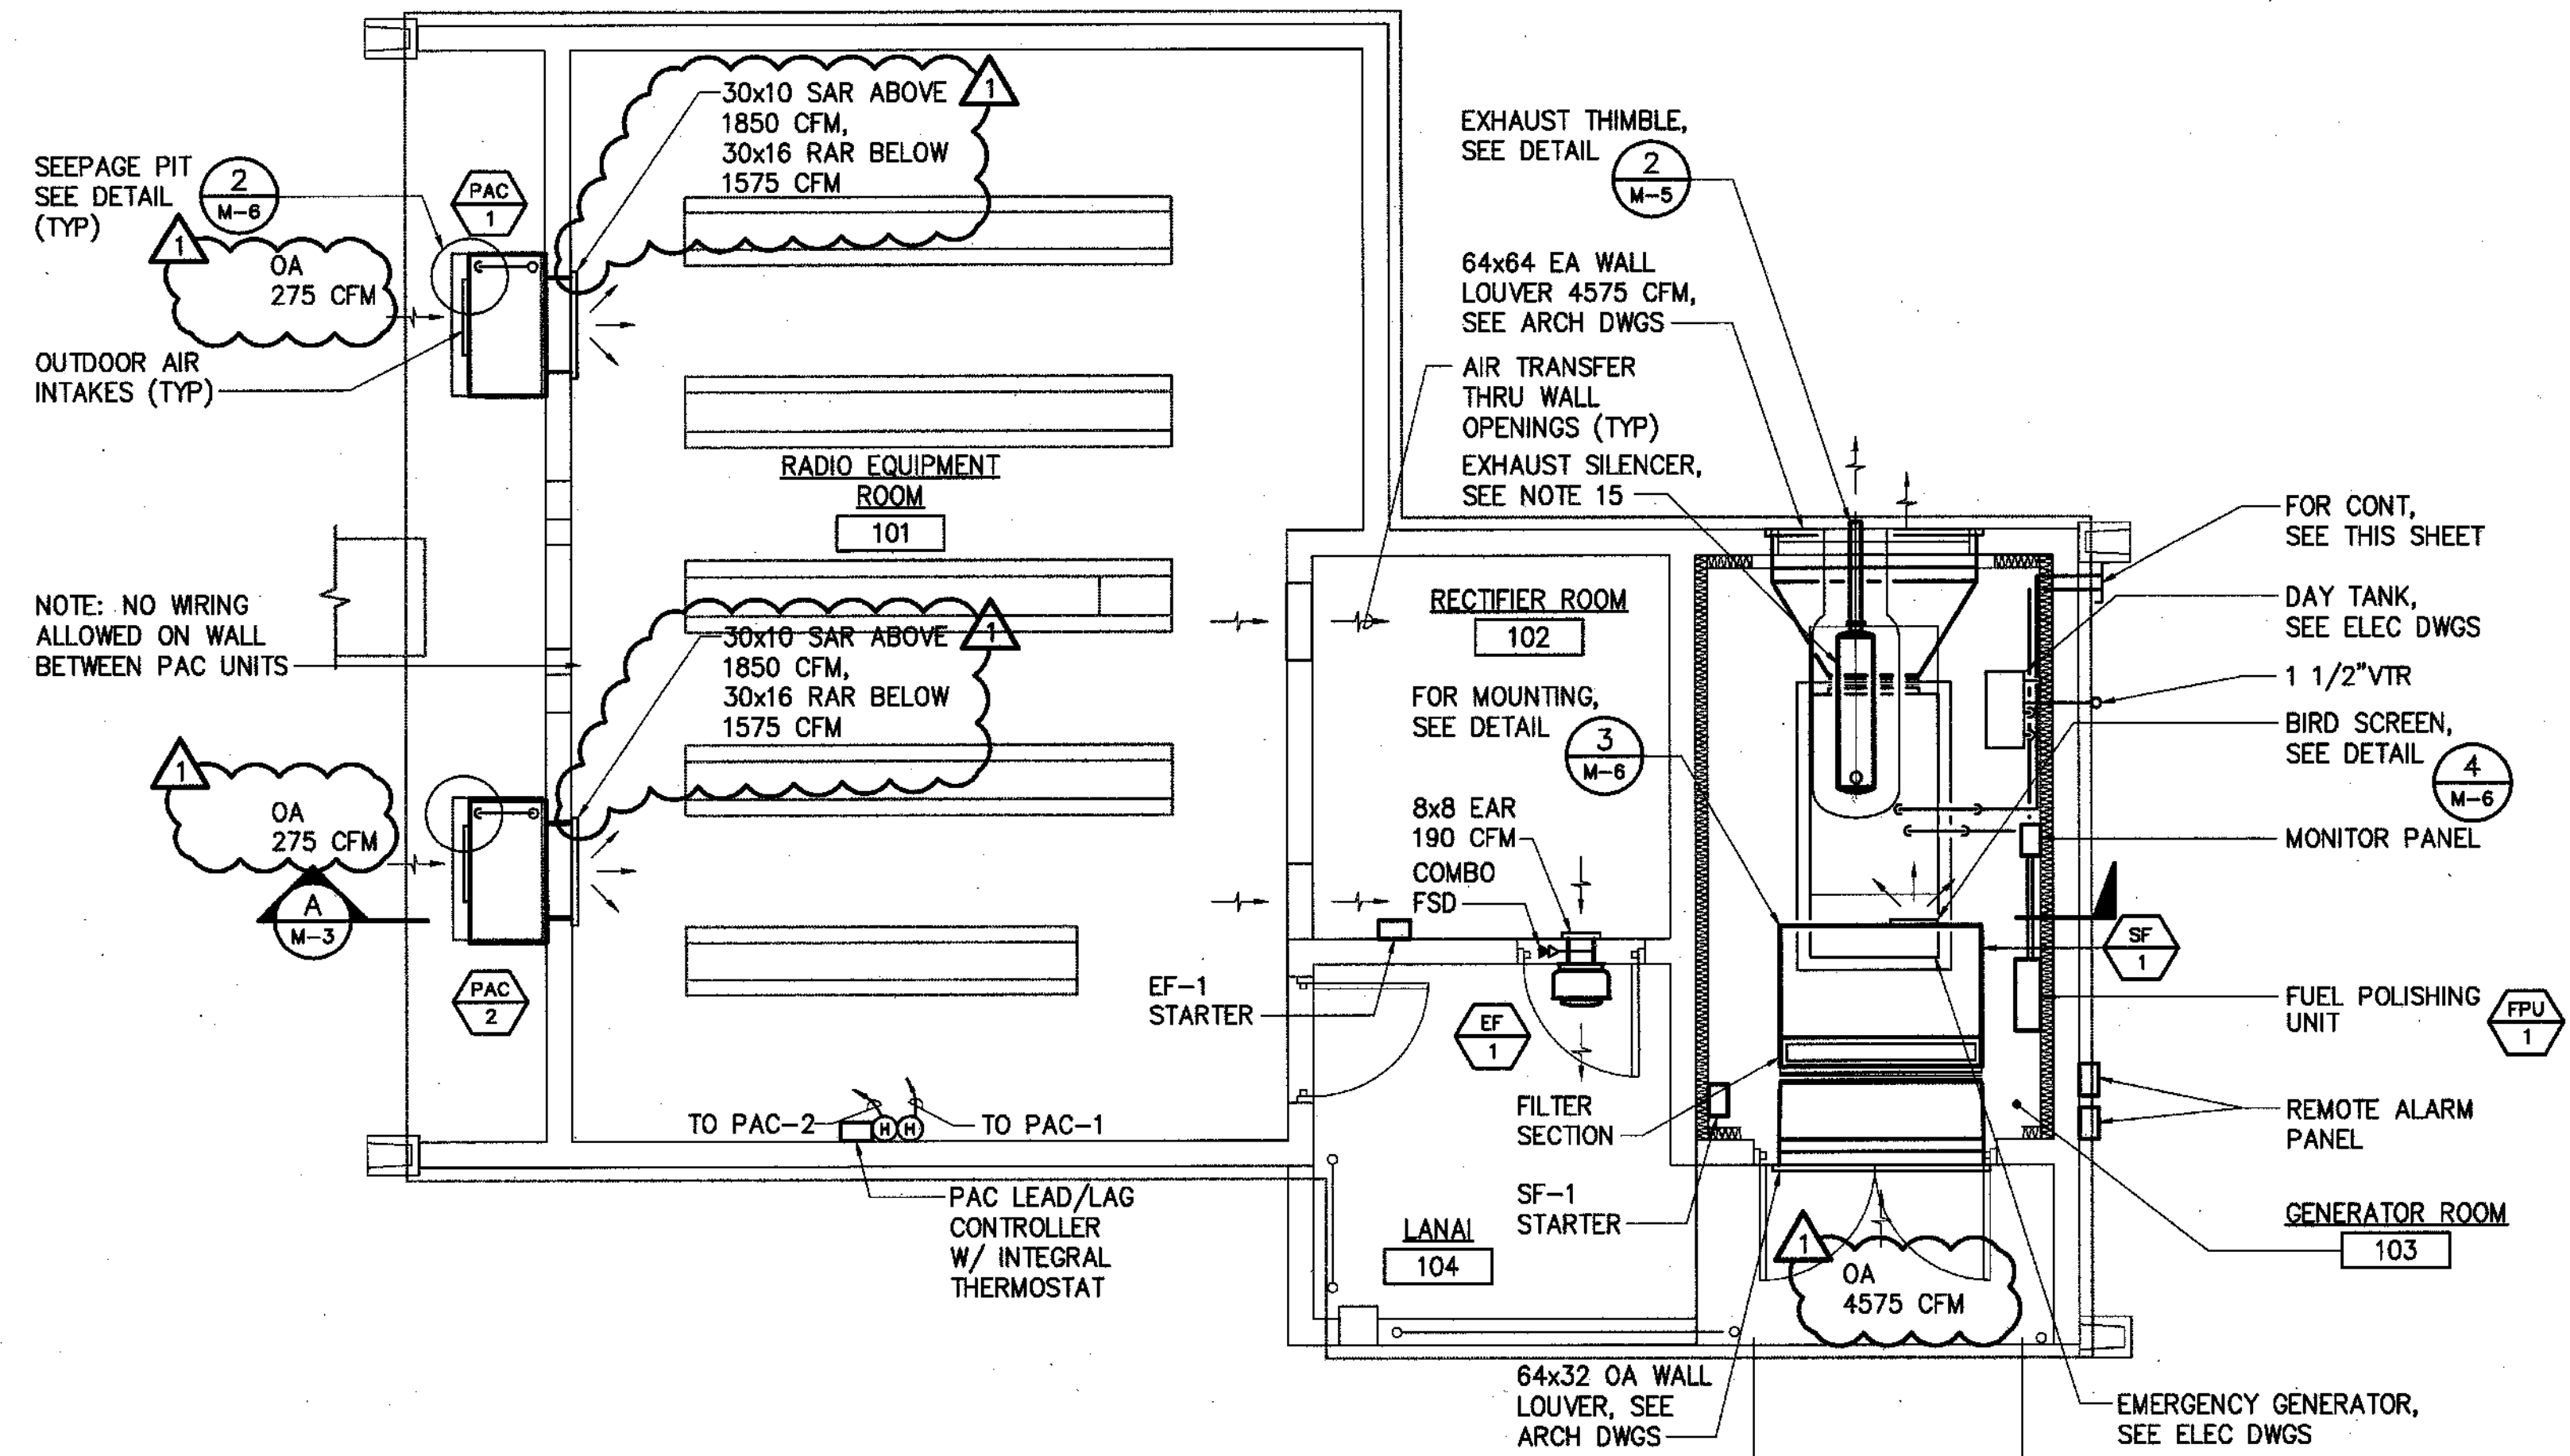

**MECHANICAL PLAN**  
SCALE: 1/4" = 1'-0"

GRAPHIC SCALE



ADD 1	1	DAGS COMMENTS	5	4/8/10	
REVISION NO.	SYM.	DESCRIPTION	SHT. OF	DATE	APPROVED: PUBLIC WORKS ADMINISTRATOR
<b>DEPT. OF ACCOUNTING &amp; GENERAL SERVICES</b> DIVISION OF PUBLIC WORKS STATE OF HAWAII <b>INFORMATION AND COMMUNICATION SERVICES DIVISION</b> <b>HILO MAUKA RADIO SITE AND TOWER</b> HILO, HAWAII T.M.K. 2-3-022:037					
<b>MECHANICAL PLAN</b>					
DESIGNED BY: SLC DRAWN BY: TEC			CHECKED BY: KMM APPROVED BY: KMM		DAGS JOB NO. 11-10-0479 DATE APR 5 2010 SCALE: AS NOTED
THIS WORK WAS PREPARED BY ME OR UNDER MY SUPERVISION  04/30/12 Expiration Date of License			DRAWING NO. M-2 SHEET 44 OF 63		